

A POTE-COCHERE ADDITION
FOR

Mr. & Mrs. Hoffman

527 Hunter's Den Dr.
Houston, TX

Residential & Commercial Builders

2133 Lou Ellen Lane
Houston, TX 77018
Ph: (713) 263-8050
Fax: (713) 263-8077

WWW.DEMAC-CONCRETE.COM



A PROJECT FOR:

Mr. & Mrs. Hoffman

PROJECT LOCATION:
527 Hunters Den
Houston, TX

REVISIONS

DESCRIPTION

BY
ALP
PERMIT & CONSTRUCTION SET 5-8-2018


JOB NO:

PLAN NO.

SCALE: 1/4" = 1'-0"

SHEET NO:

1

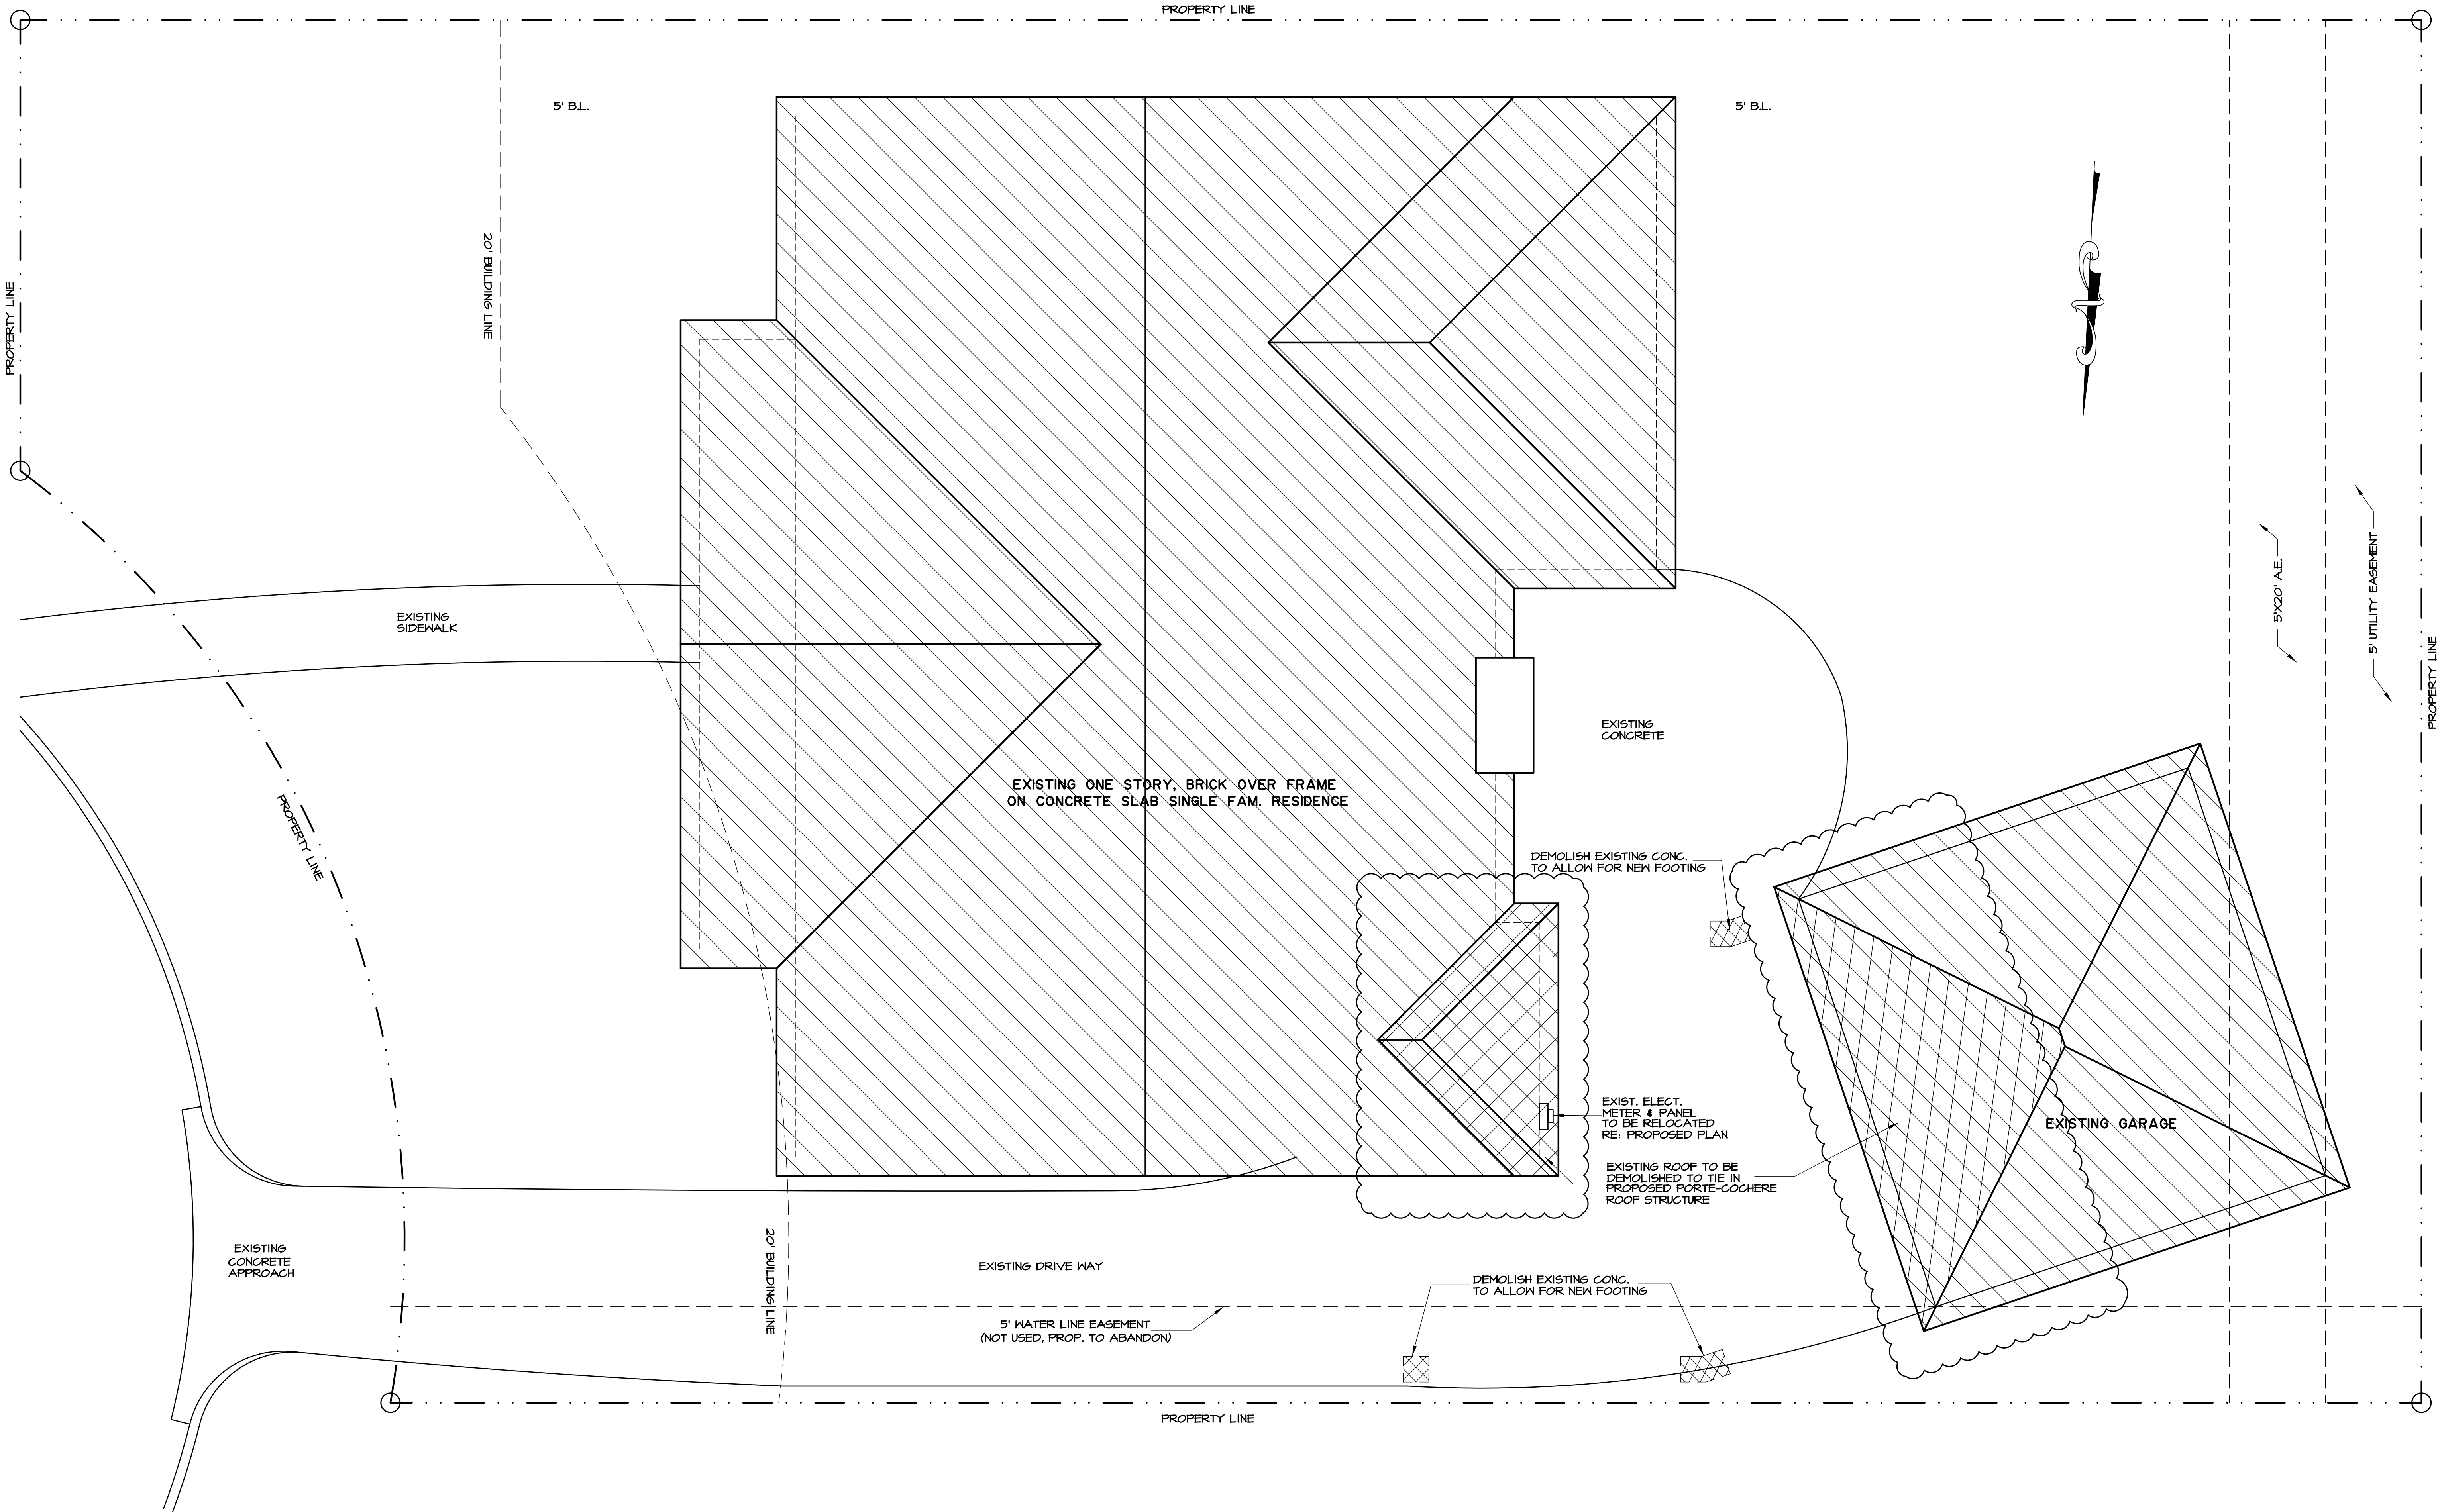

lot 15
block 3
of Ashford Forest
subdivision

existing site and
demolition plan
SCALE: 1/4"=1'-0"


Residential & Commercial Builders
2133 Lou Ellen Lane
Houston, TX 77018
Ph: (713) 263-8050
Fax: (713) 263-8077
WWW.DEMAC-CONCRETE.COM



A PROJECT FOR:
Mr. & Mrs. Hoffman
PROJECT LOCATION:
527 Hunters Den
Houston, TX

REVISIONS		DESCRIPTION
BY	ALP	PERMIT & CONSTRUCTION SET 5-8-2018

JOB NO:
PLAN NO.
SCALE: 1/4" = 1'-0"
SHEET NO:
2

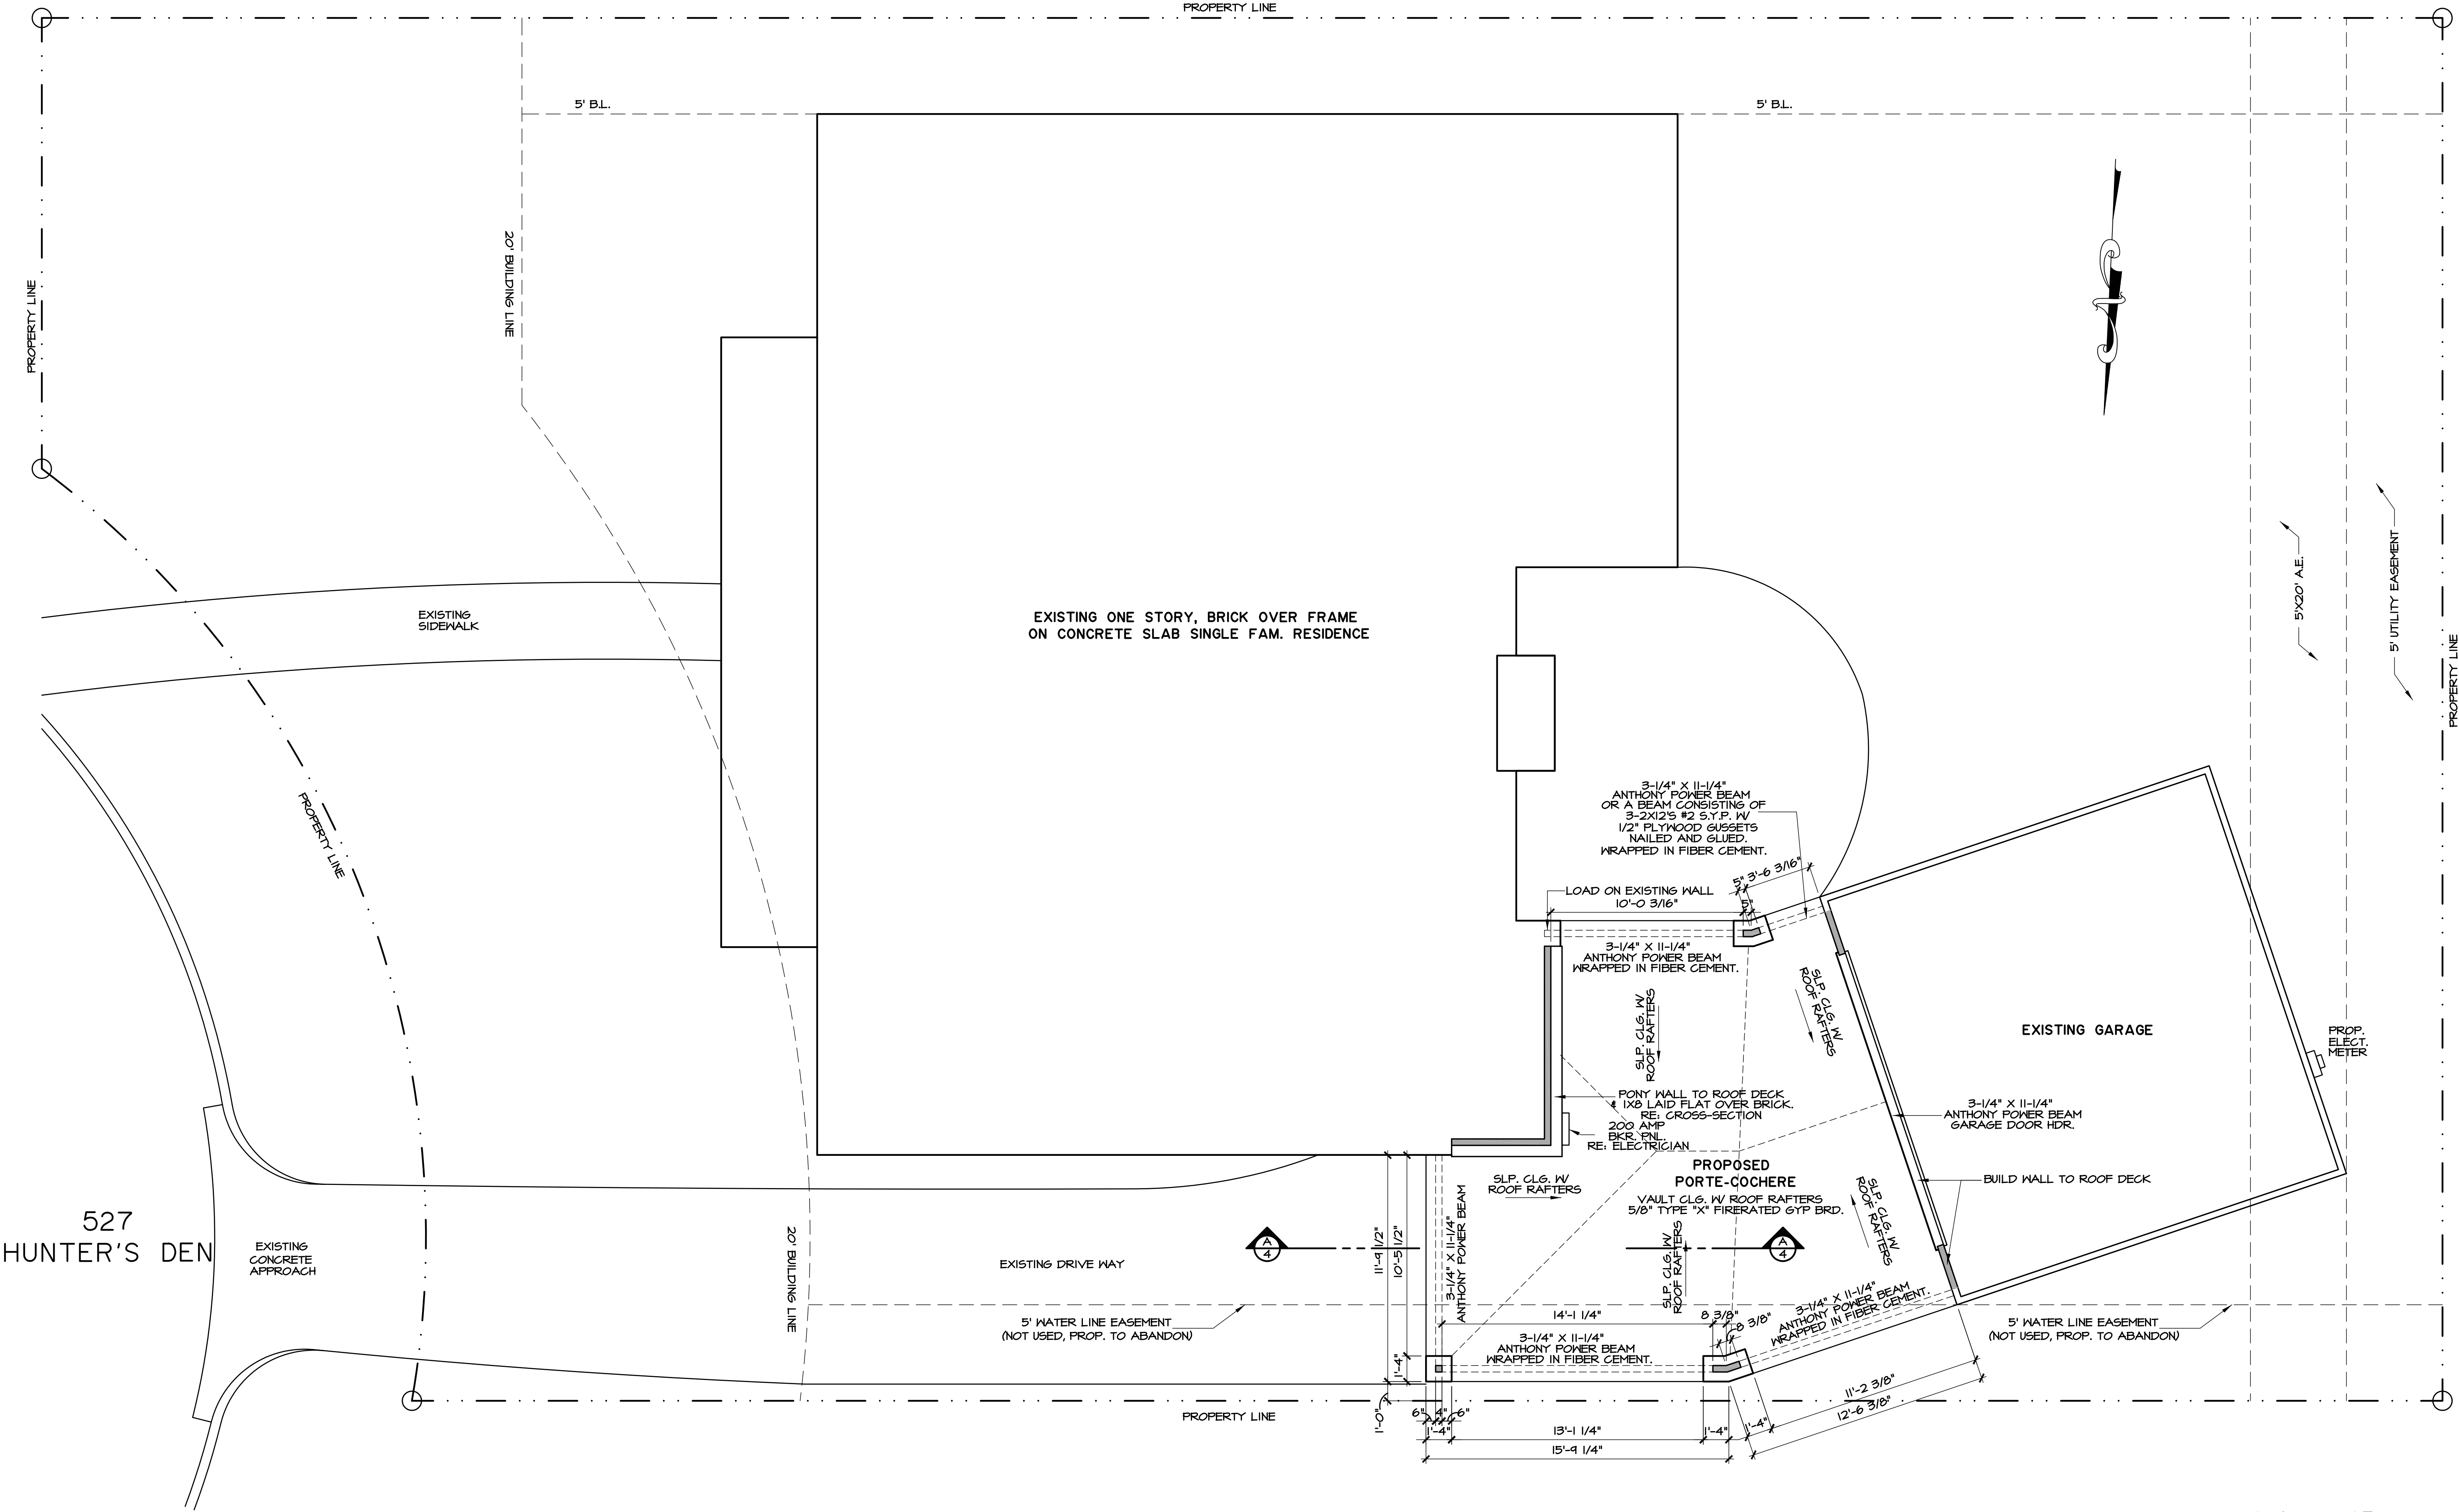

527
HUNTER'S DEN

lot 15
block 3
of Ashford Forest
subdivision

proposed site
and floor plan

SCALE: 1/4"=1'-0"

Residential & Commercial Builders
2133 Lou Ellen Lane
Houston, TX 77018
Ph: (713) 263-8050
Fax: (713) 263-8077
WWW.DEMAC-CONCRETE.COM




A PROJECT FOR:
Mr. & Mrs. Hoffman
PROJECT LOCATION:
527 Hunters Den
Houston, TX


REVISIONS		DESCRIPTION
BY	ALP	PERMIT & CONSTRUCTION SET 5-8-2018

JOB NO:
PLAN NO.
SCALE: 1/4" = 1'-0"


SHEET NO:
3

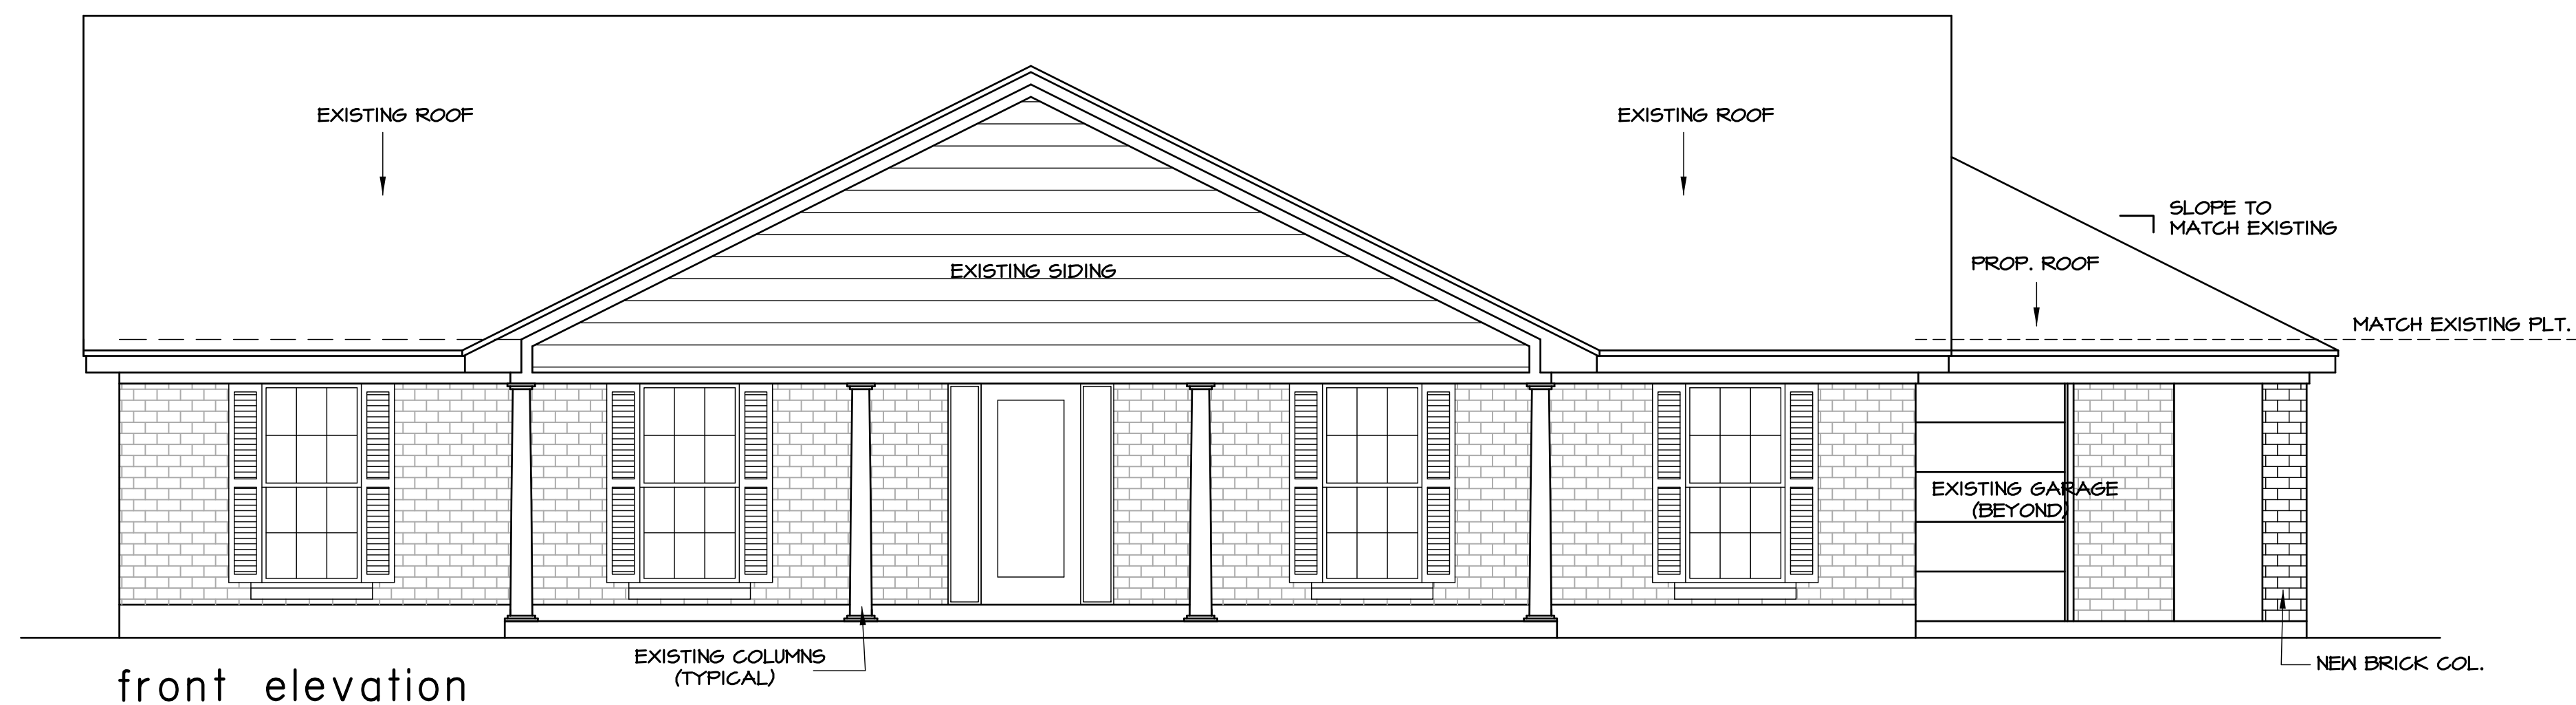


front elevation

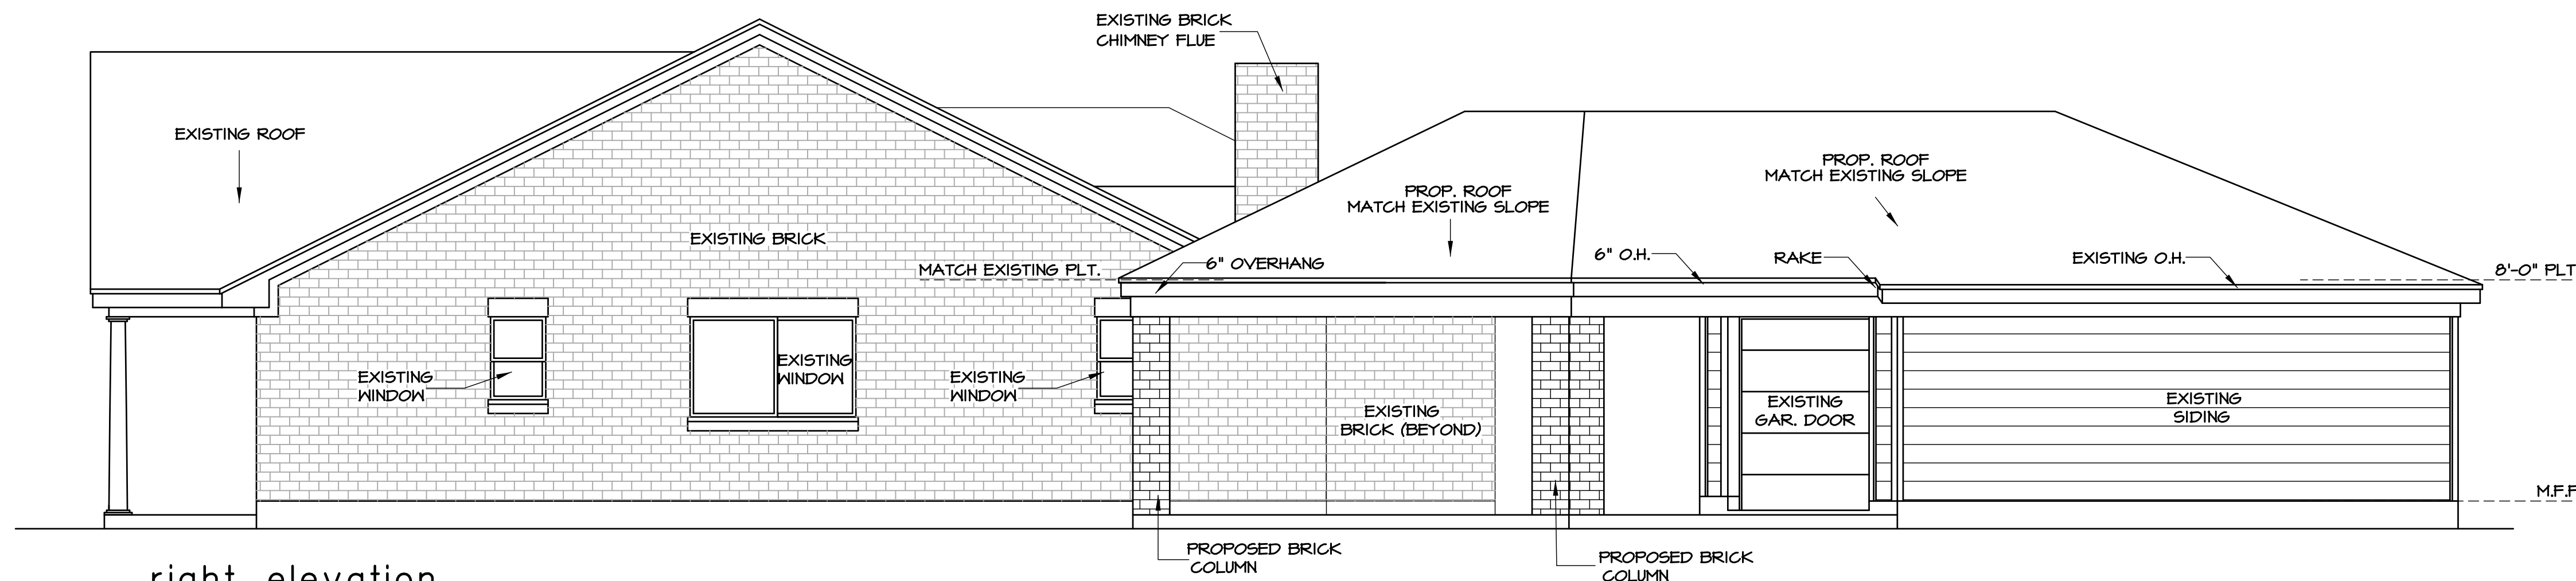


right elevation

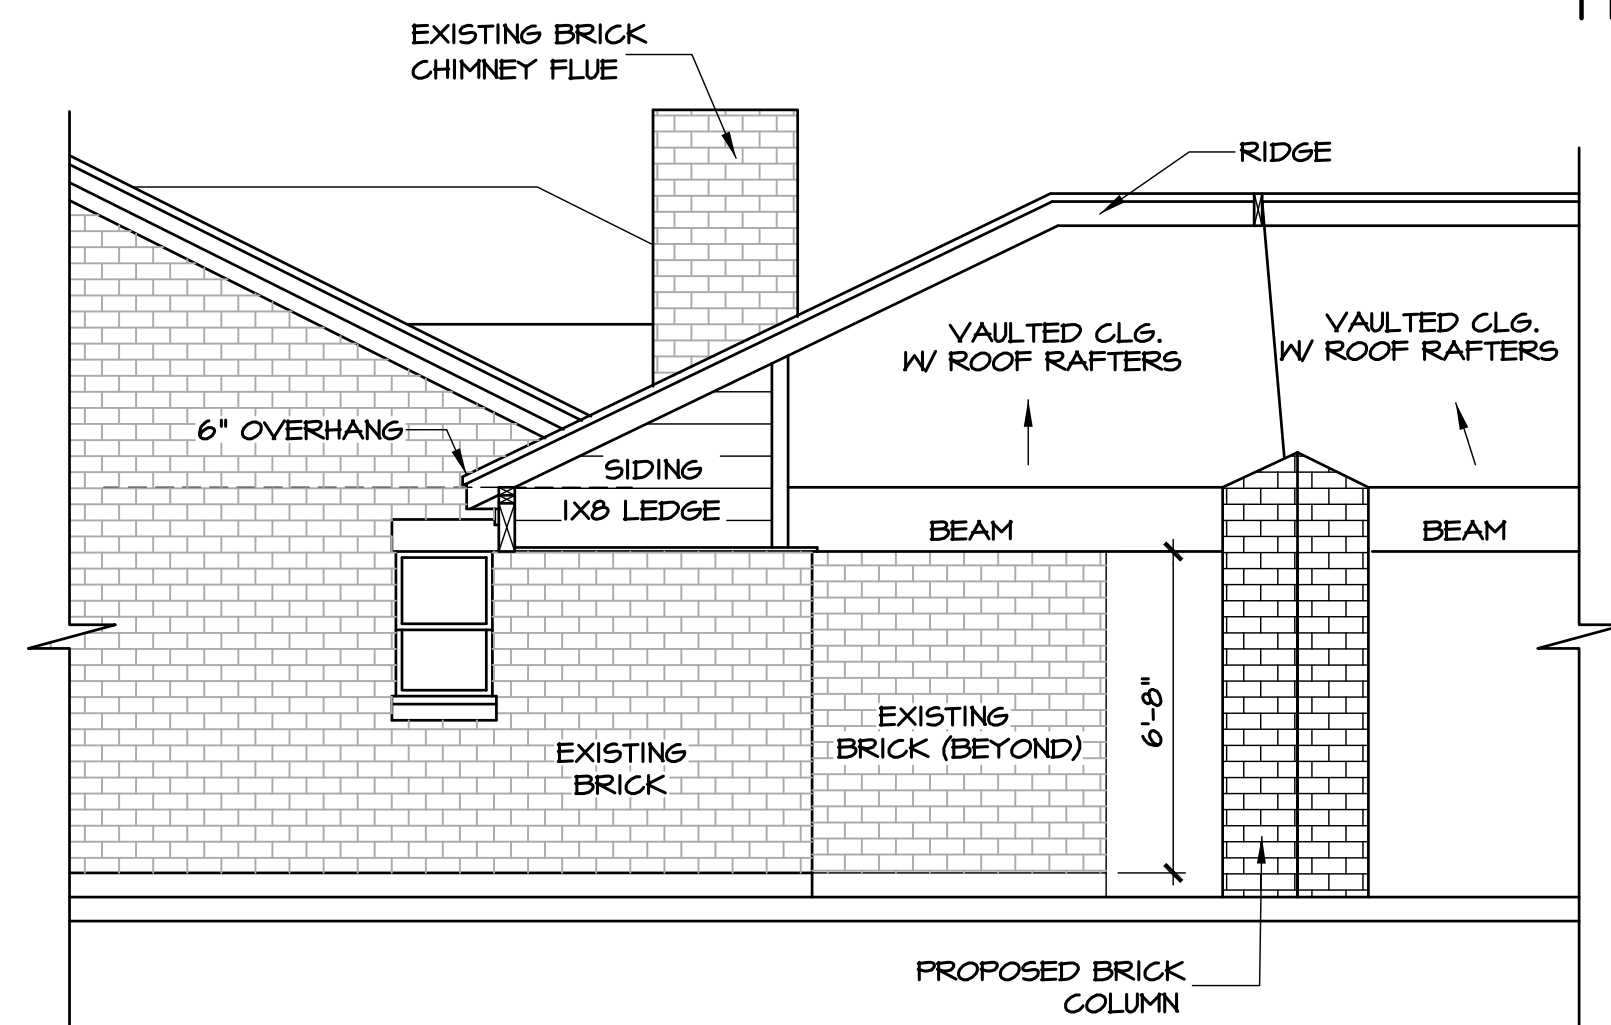

 A-building cross section

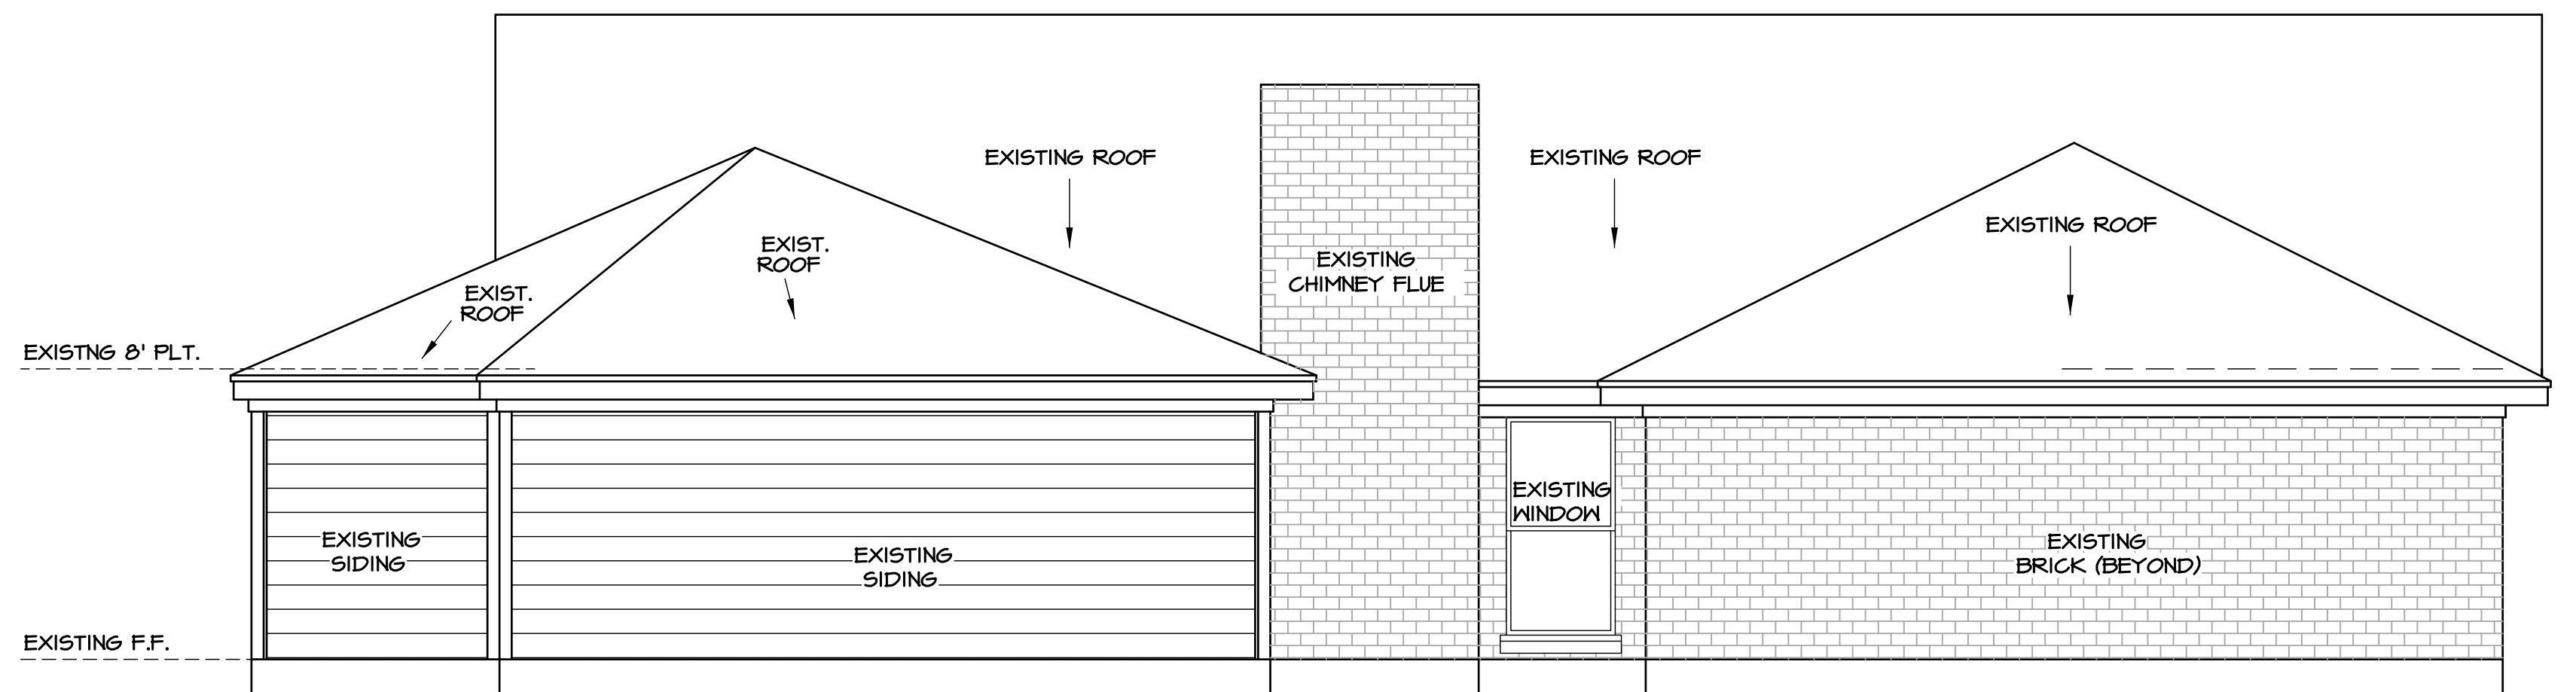

rear elevation

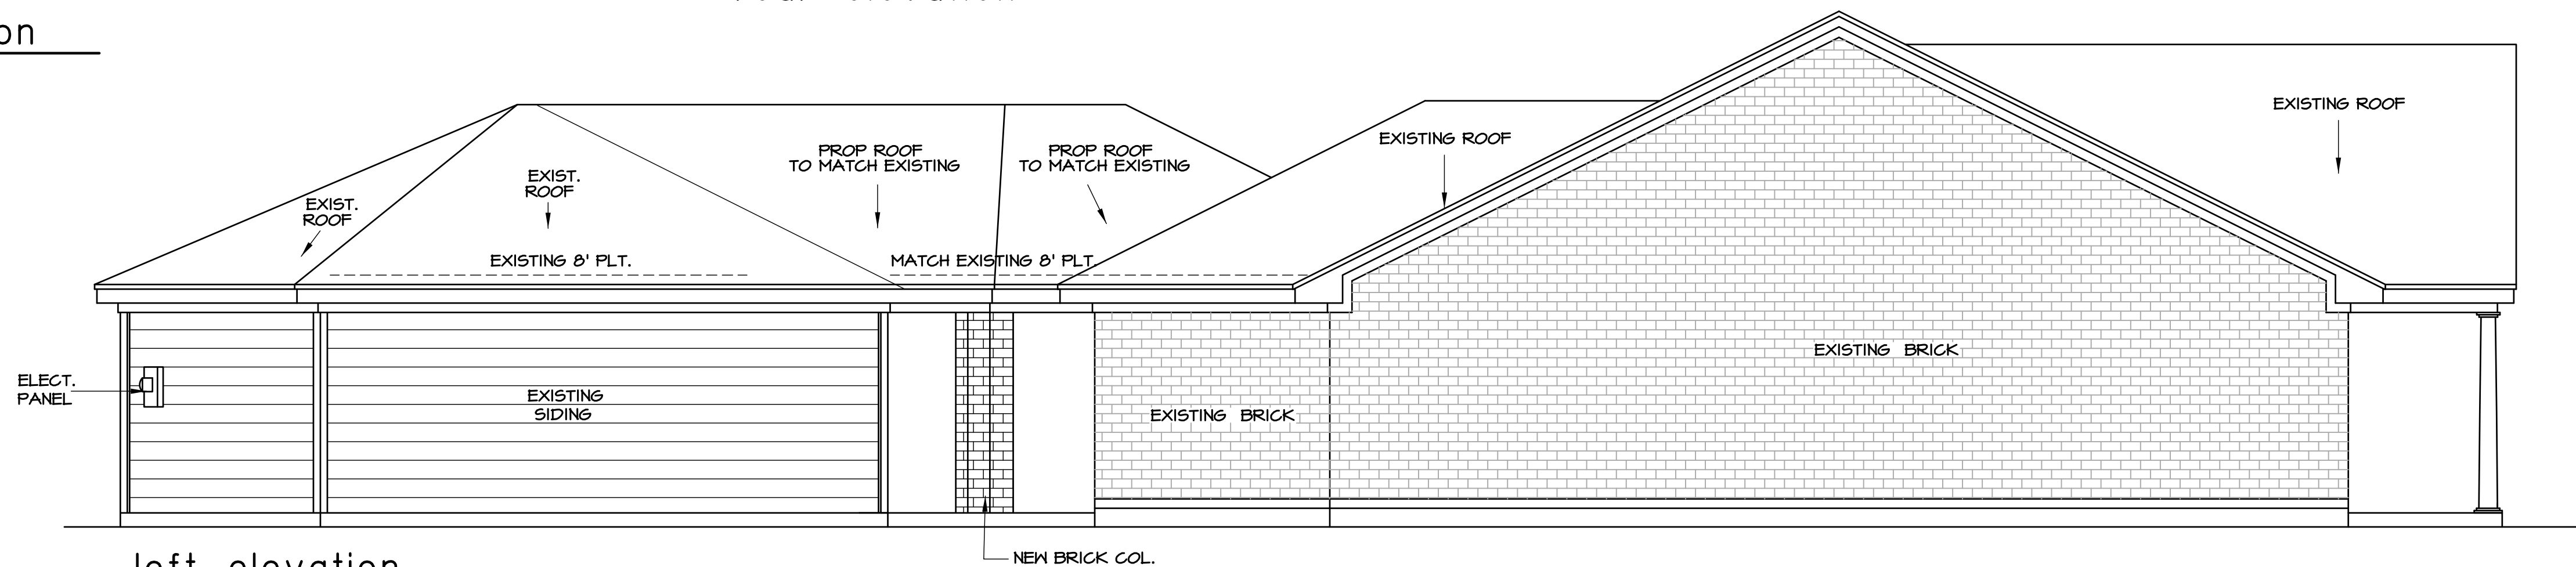

left elevation

proposed
exterior elevations
SCALE: 1/4"=1'-0"


Residential & Commercial Builders
2133 Lou Ellen Lane
Houston, TX 77018
Ph: (713) 263-8050
Fax: (713) 263-8077
WWW.DEMAC-CONCRETE.COM




A PROJECT FOR:
Mr. & Mrs. Hoffman
PROJECT LOCATION:
527 Hunters Den
Houston, TX

REVISIONS		DESCRIPTION
BY		
ALP		PERMIT & CONSTRUCTION SET 5-8-2018

JOB NO:
PLAN NO.
SCALE: 1/4" = 1'-0"
SHEET NO:
4

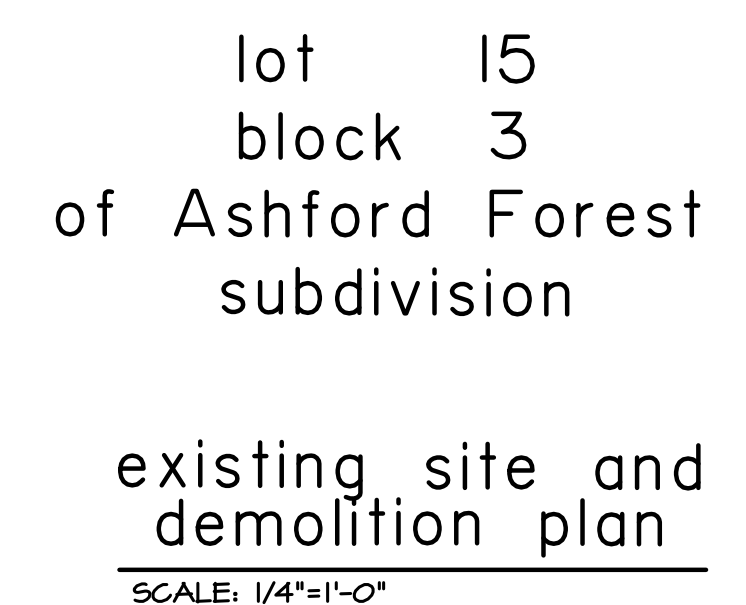

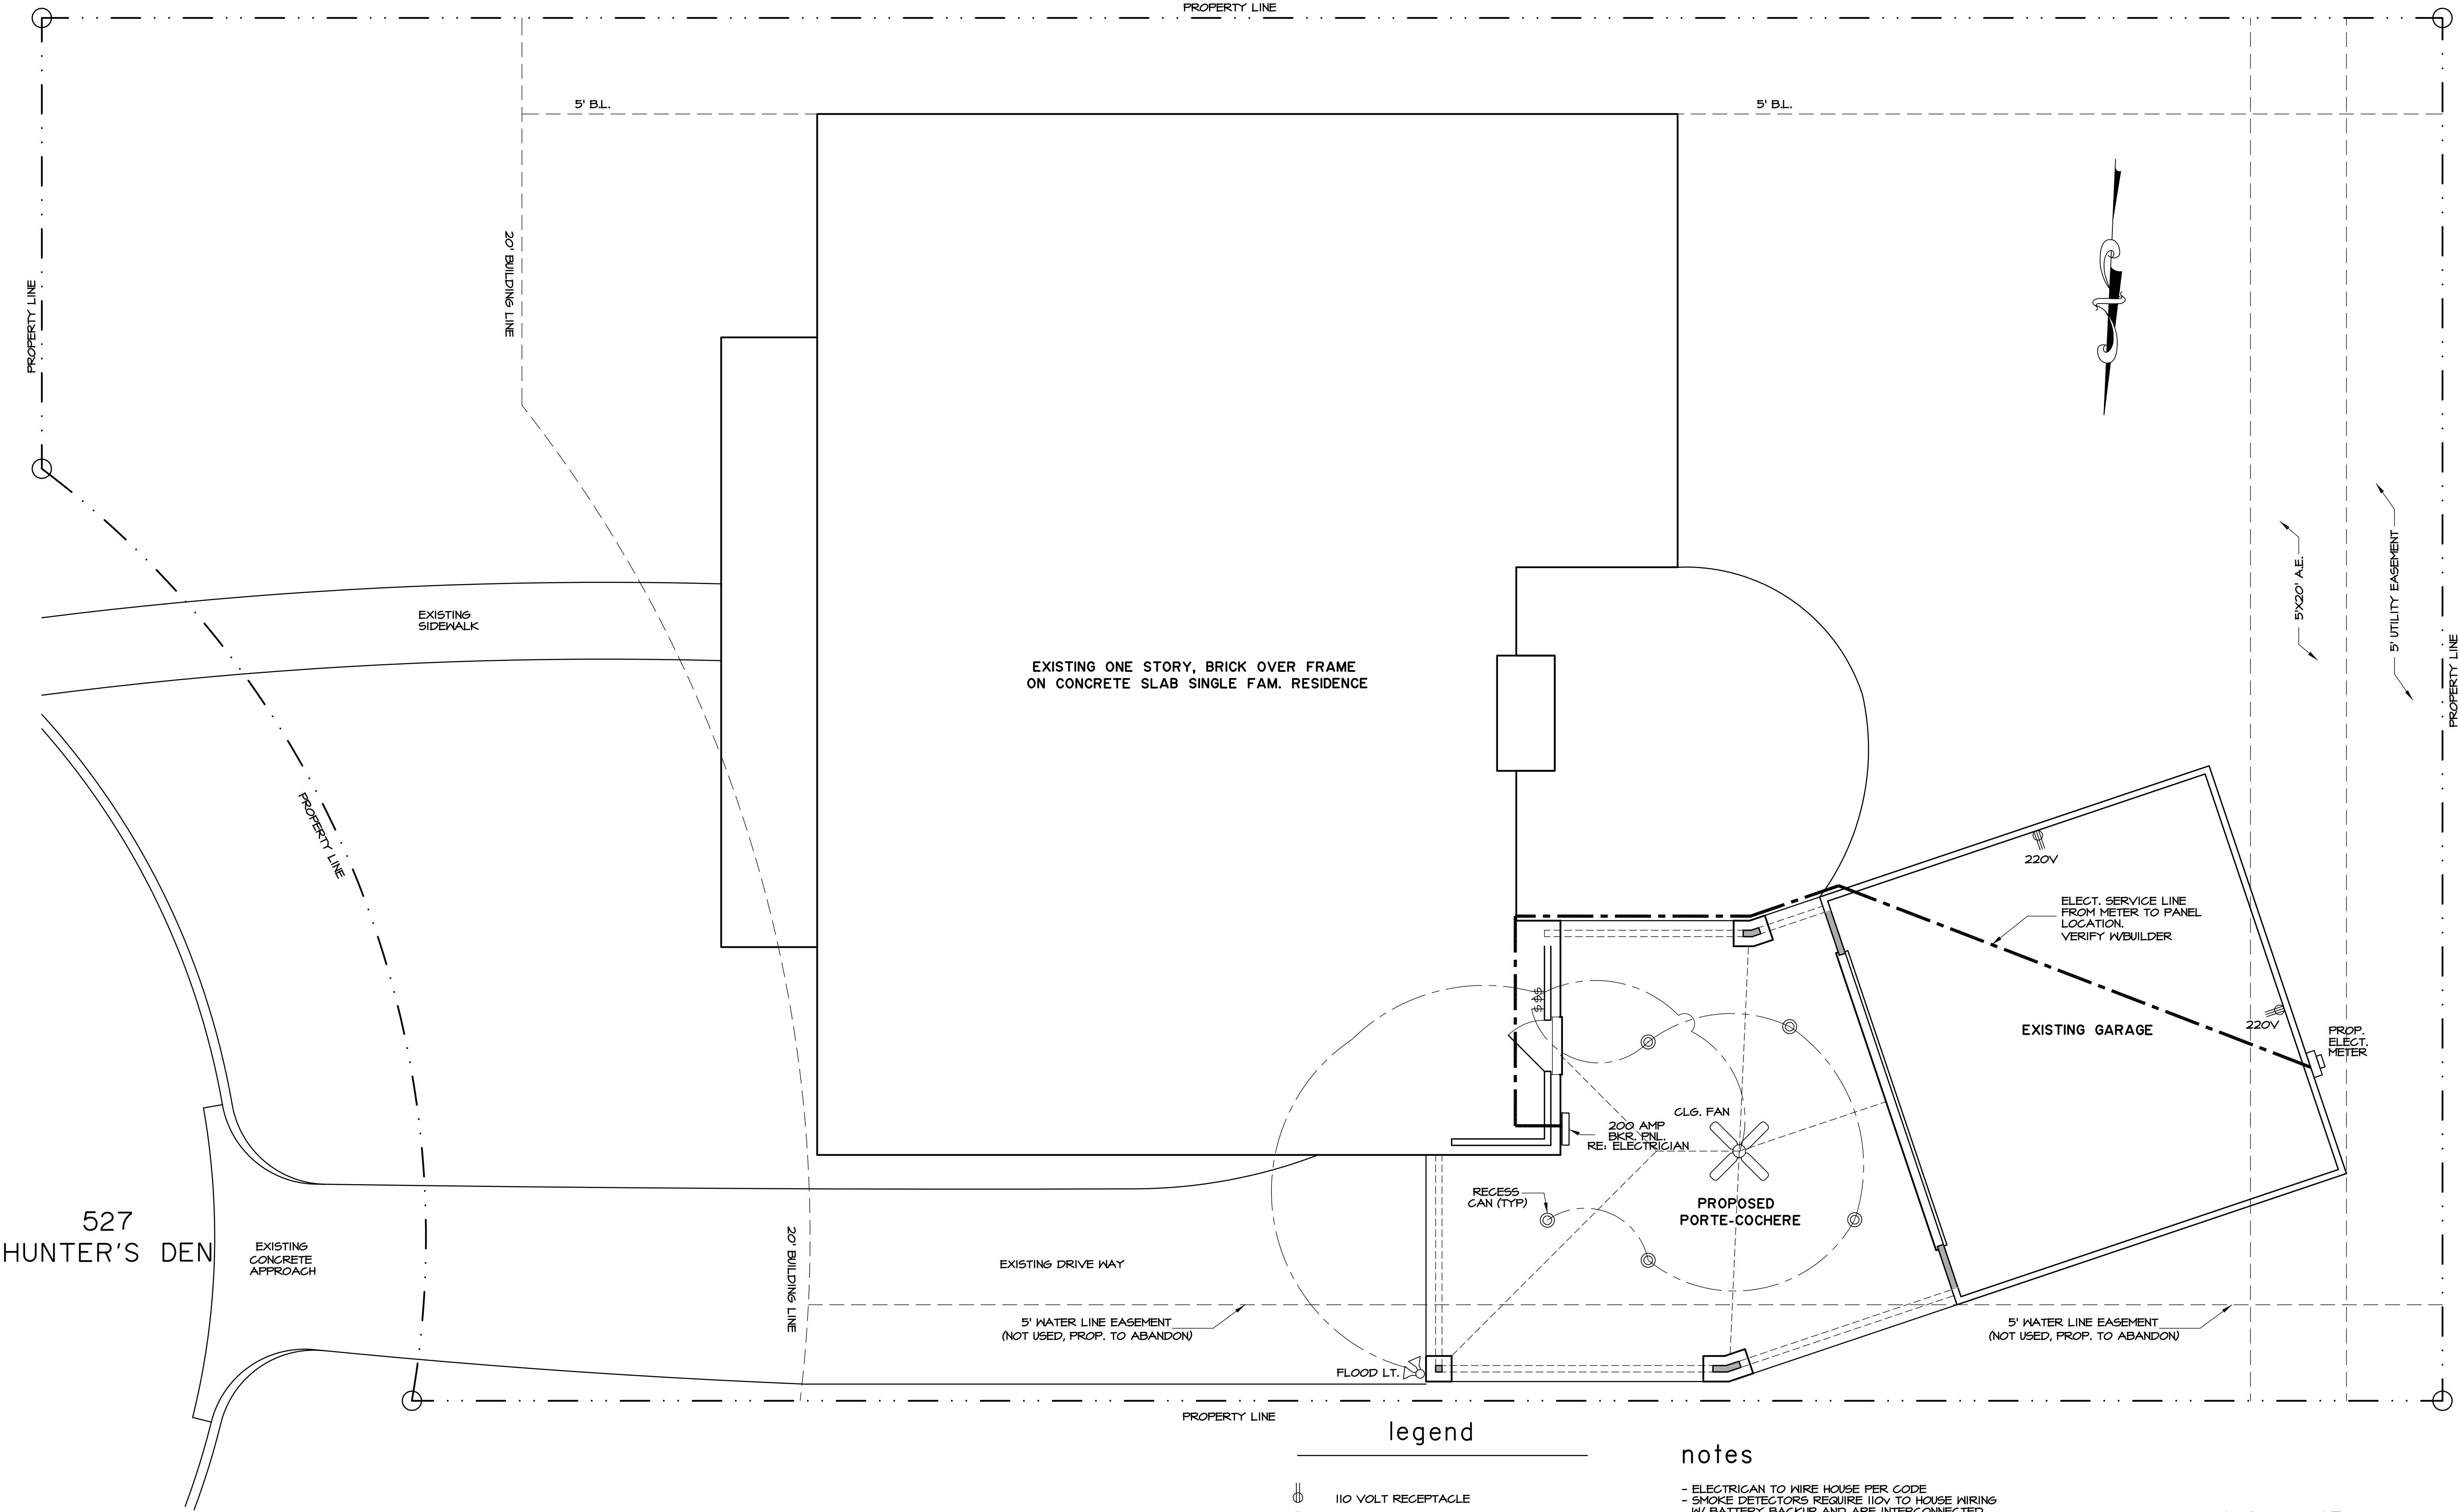

legend

	110 VOLT RECEPTACLE
	WATERPROOF RECEPTACLE
	110 VOLT W/ GROUND FAULT INTERRUPTOR
	220 VOLT RECEPTACLE
	SINGLE POLE SWITCH
	RECESSED CAN LIGHT
	FLOOD LIGHTS
	CEILING FAN

- notes
- ELECTRICIAN TO WIRE HOUSE PER CODE
 - SMOKE DETECTORS REQUIRE 110V TO HOUSE WIRING W/ BATTERY BACKUP AND ARE INTERCONNECTED.
 - VENT ALL EXHAUST FANS TO OUTSIDE
 - PROVIDE G.F.I. PROTECTION AS REQ'D.
 - PROVIDE LIGHT FIXTURE AND SMOKE DETECTORS AT EACH WATER HEATER AND A/C UNIT LOCATION IN ATTIC
 - PROVIDE ELECTRIC DISCONNECT AT EACH A/C UNIT
 - ALLOW FOR A/C UNITS
 - PROVIDE LOW VOLTAGE CIRCUITS FOR BURGLAR ALARM SYSTEM
 - PROVIDE LOW VOLTAGE CIRCUITS FOR INTERCOM SYSTEM W/ BASE AND SPEAKER LOCATIONS BY OWNER
 - PROVIDE CIRCUITS FOR FUTURE POOL AND REAR YARD LIGHTING
 - OUTLETS AT BEDROOMS TO BE ARC PROTECTED AND ON SEPERATE CIRCUITS FROM CLG. FANS.

lot 15
block 3
of Ashford Forest
subdivision

proposed site
and electrical floor plan

SCALE: 1/4"=1'-0"

REVISIONS		DESCRIPTION
BY	ALP	PERMIT & CONSTRUCTION SET 5-8-2018
JOB NO:		PLAN NO.
SCALE: 1/4" = 1'-0"		SHEET NO:
		6

Residential & Commercial Builders

DEMAG
& Company

Commercial & Industrial Concrete Contractors

A PROJECT FOR:

Mr. & Mrs. Hoffman

PROJECT LOCATION:
527 Hunters Den
Houston, TX

2133 Lou Ellen Lane
Houston, TX 77018
Ph: (713) 263-8050
Fax: (713) 263-8077

WWW.DEMAG-CONCRETE.COM