



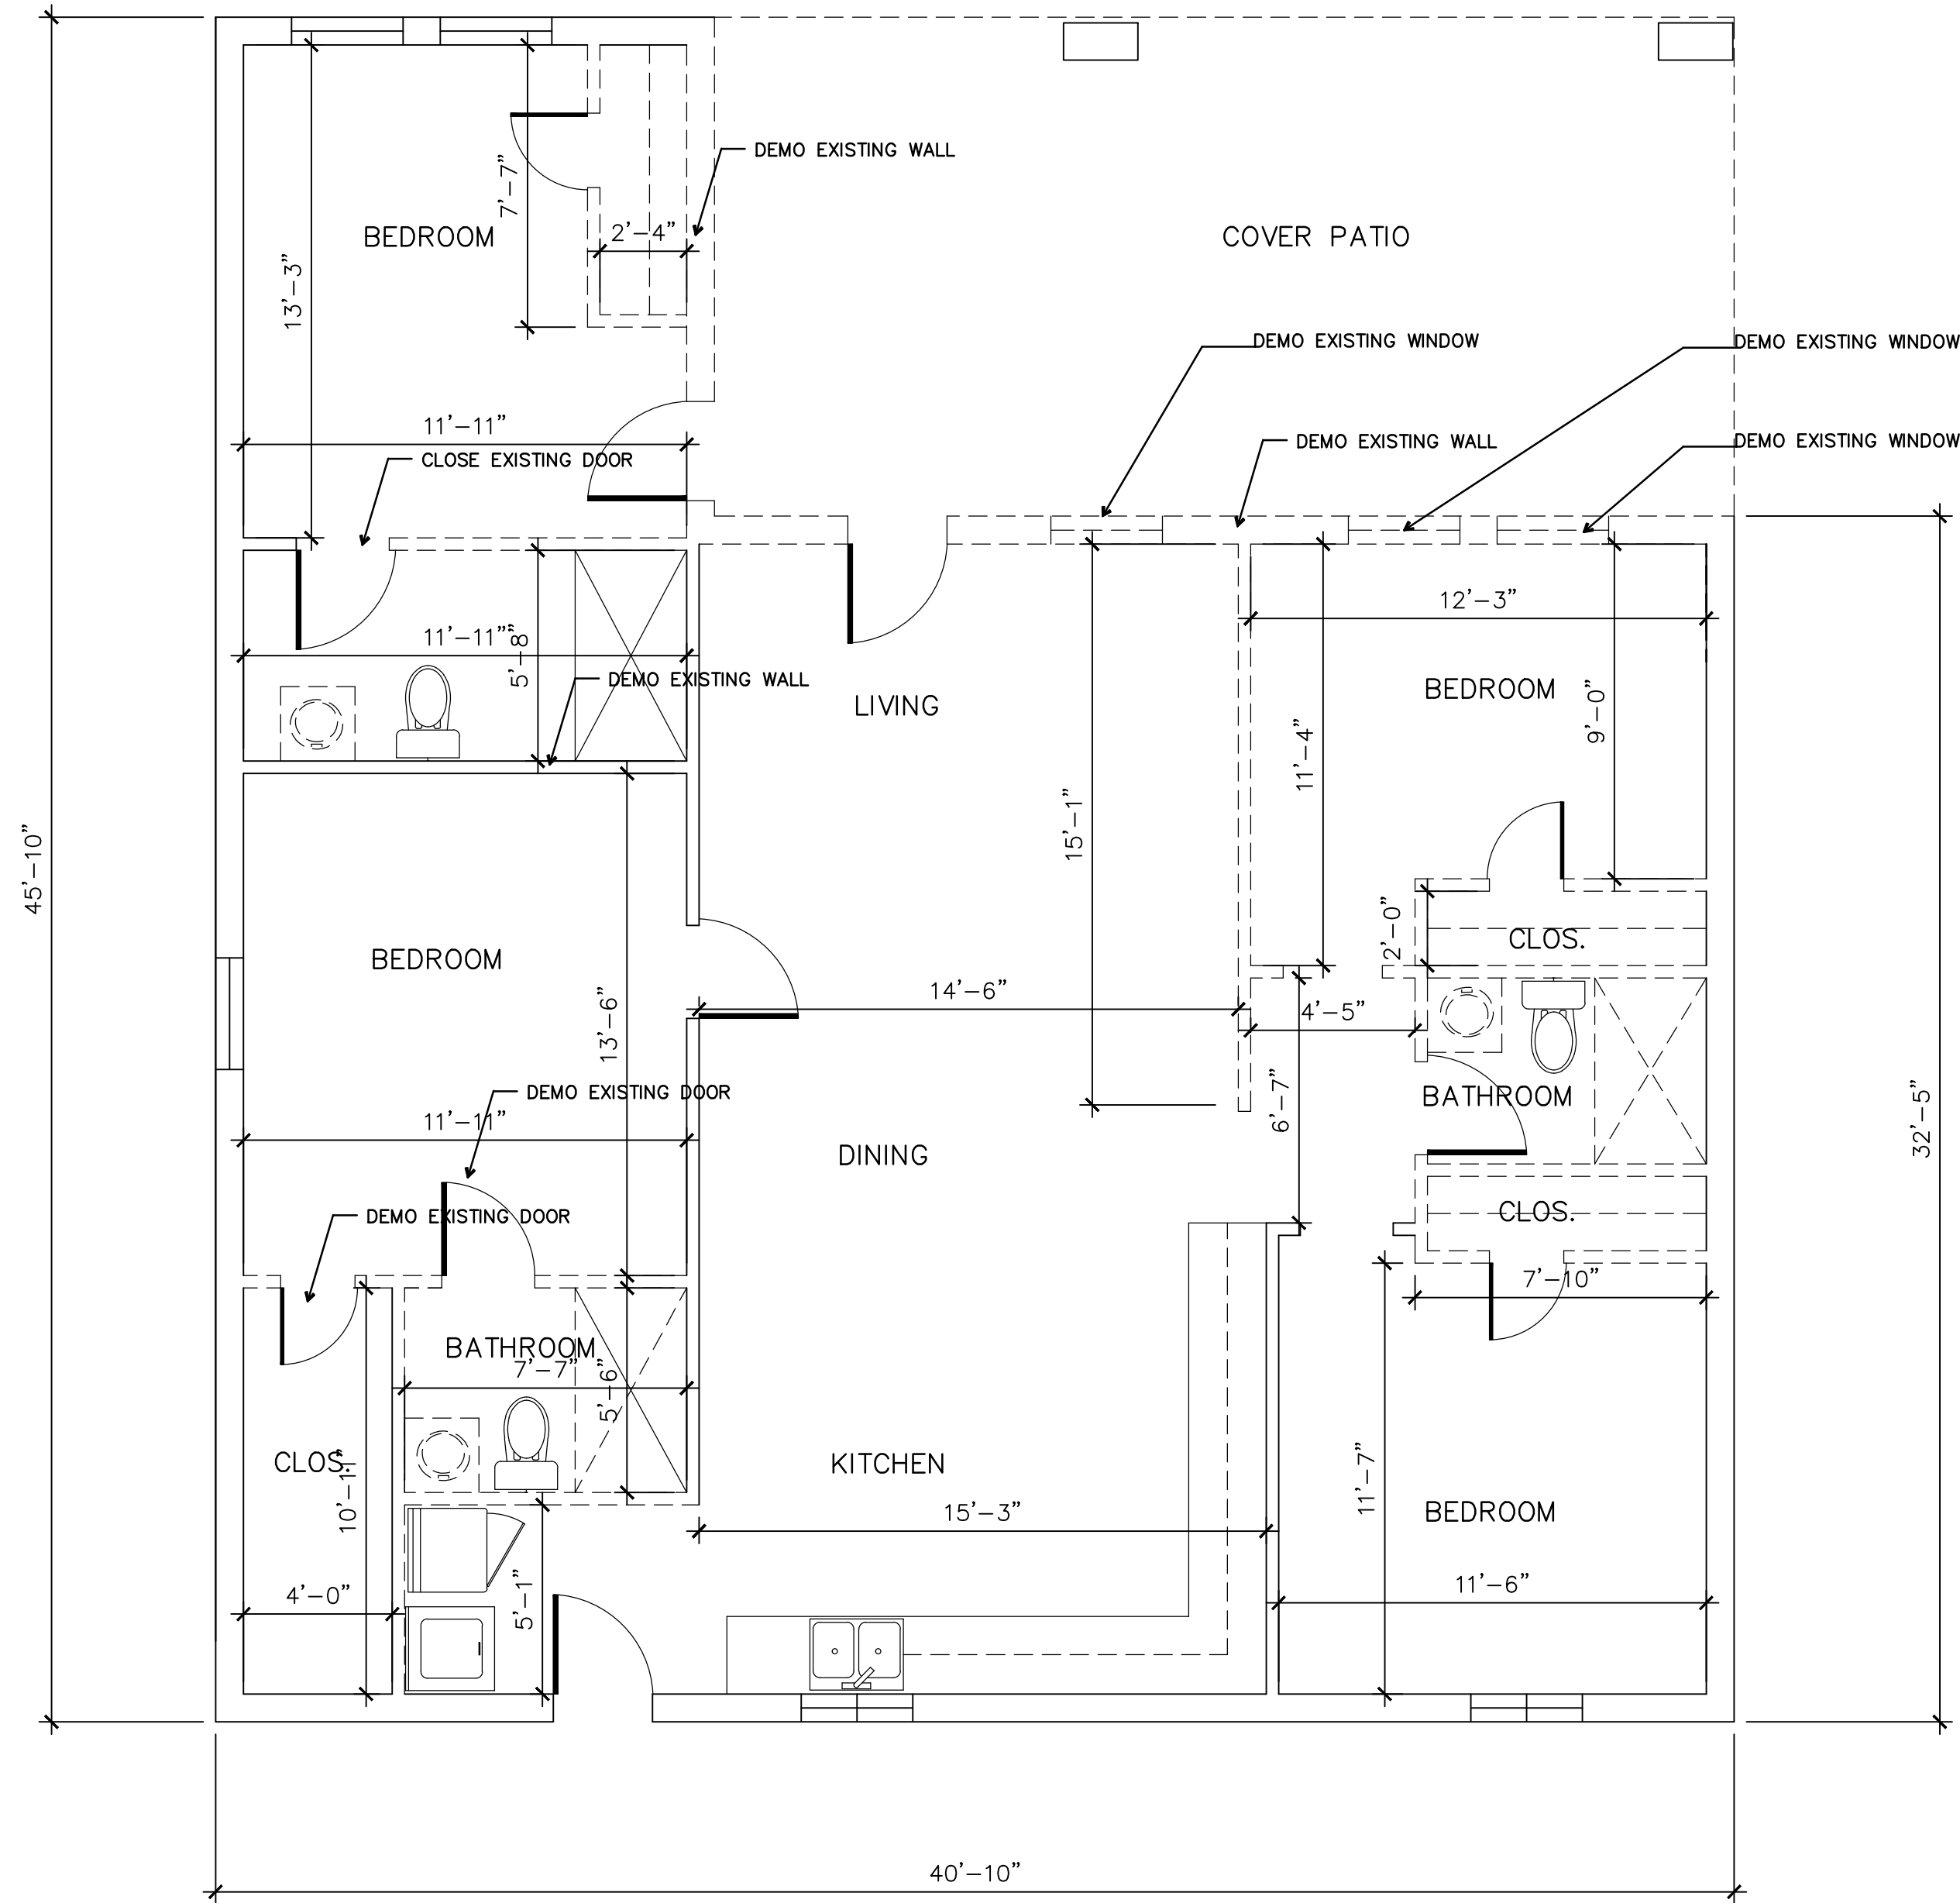

1
A1-0
EXISTING DEMO FLOOR PLAN
SCALE 1/4"=1'-0"

- GENERAL NOTES:
1. FIELD VERIFY EXISTING FINISH FLOOR ELEVATION
 2. ALL PORCHED WALLS SHALL BE REPRESENTED AS NEW WALLS
 3. NEW DOORS SHALL BE REPRESENT WITH SYMBOL NUMBERS
 4. ALL NEW WINDOWS SHALL BE REPRESENTED WITH SYMBOL LETTERS
 5. REMOVE EXISTING WINDOWS AND REPLACE W/ FIELD VERIFY EXISTING SIZE
NEW (FIELD VERIFY TO MATCH EXISTING SIZE)
 6. REMOVE AND STORAGE PLUMBING FIXTURE FOR REPLACEMENT AND REUSED

DEMODOED WALLS
EXISTING WALLS TO REMAIN

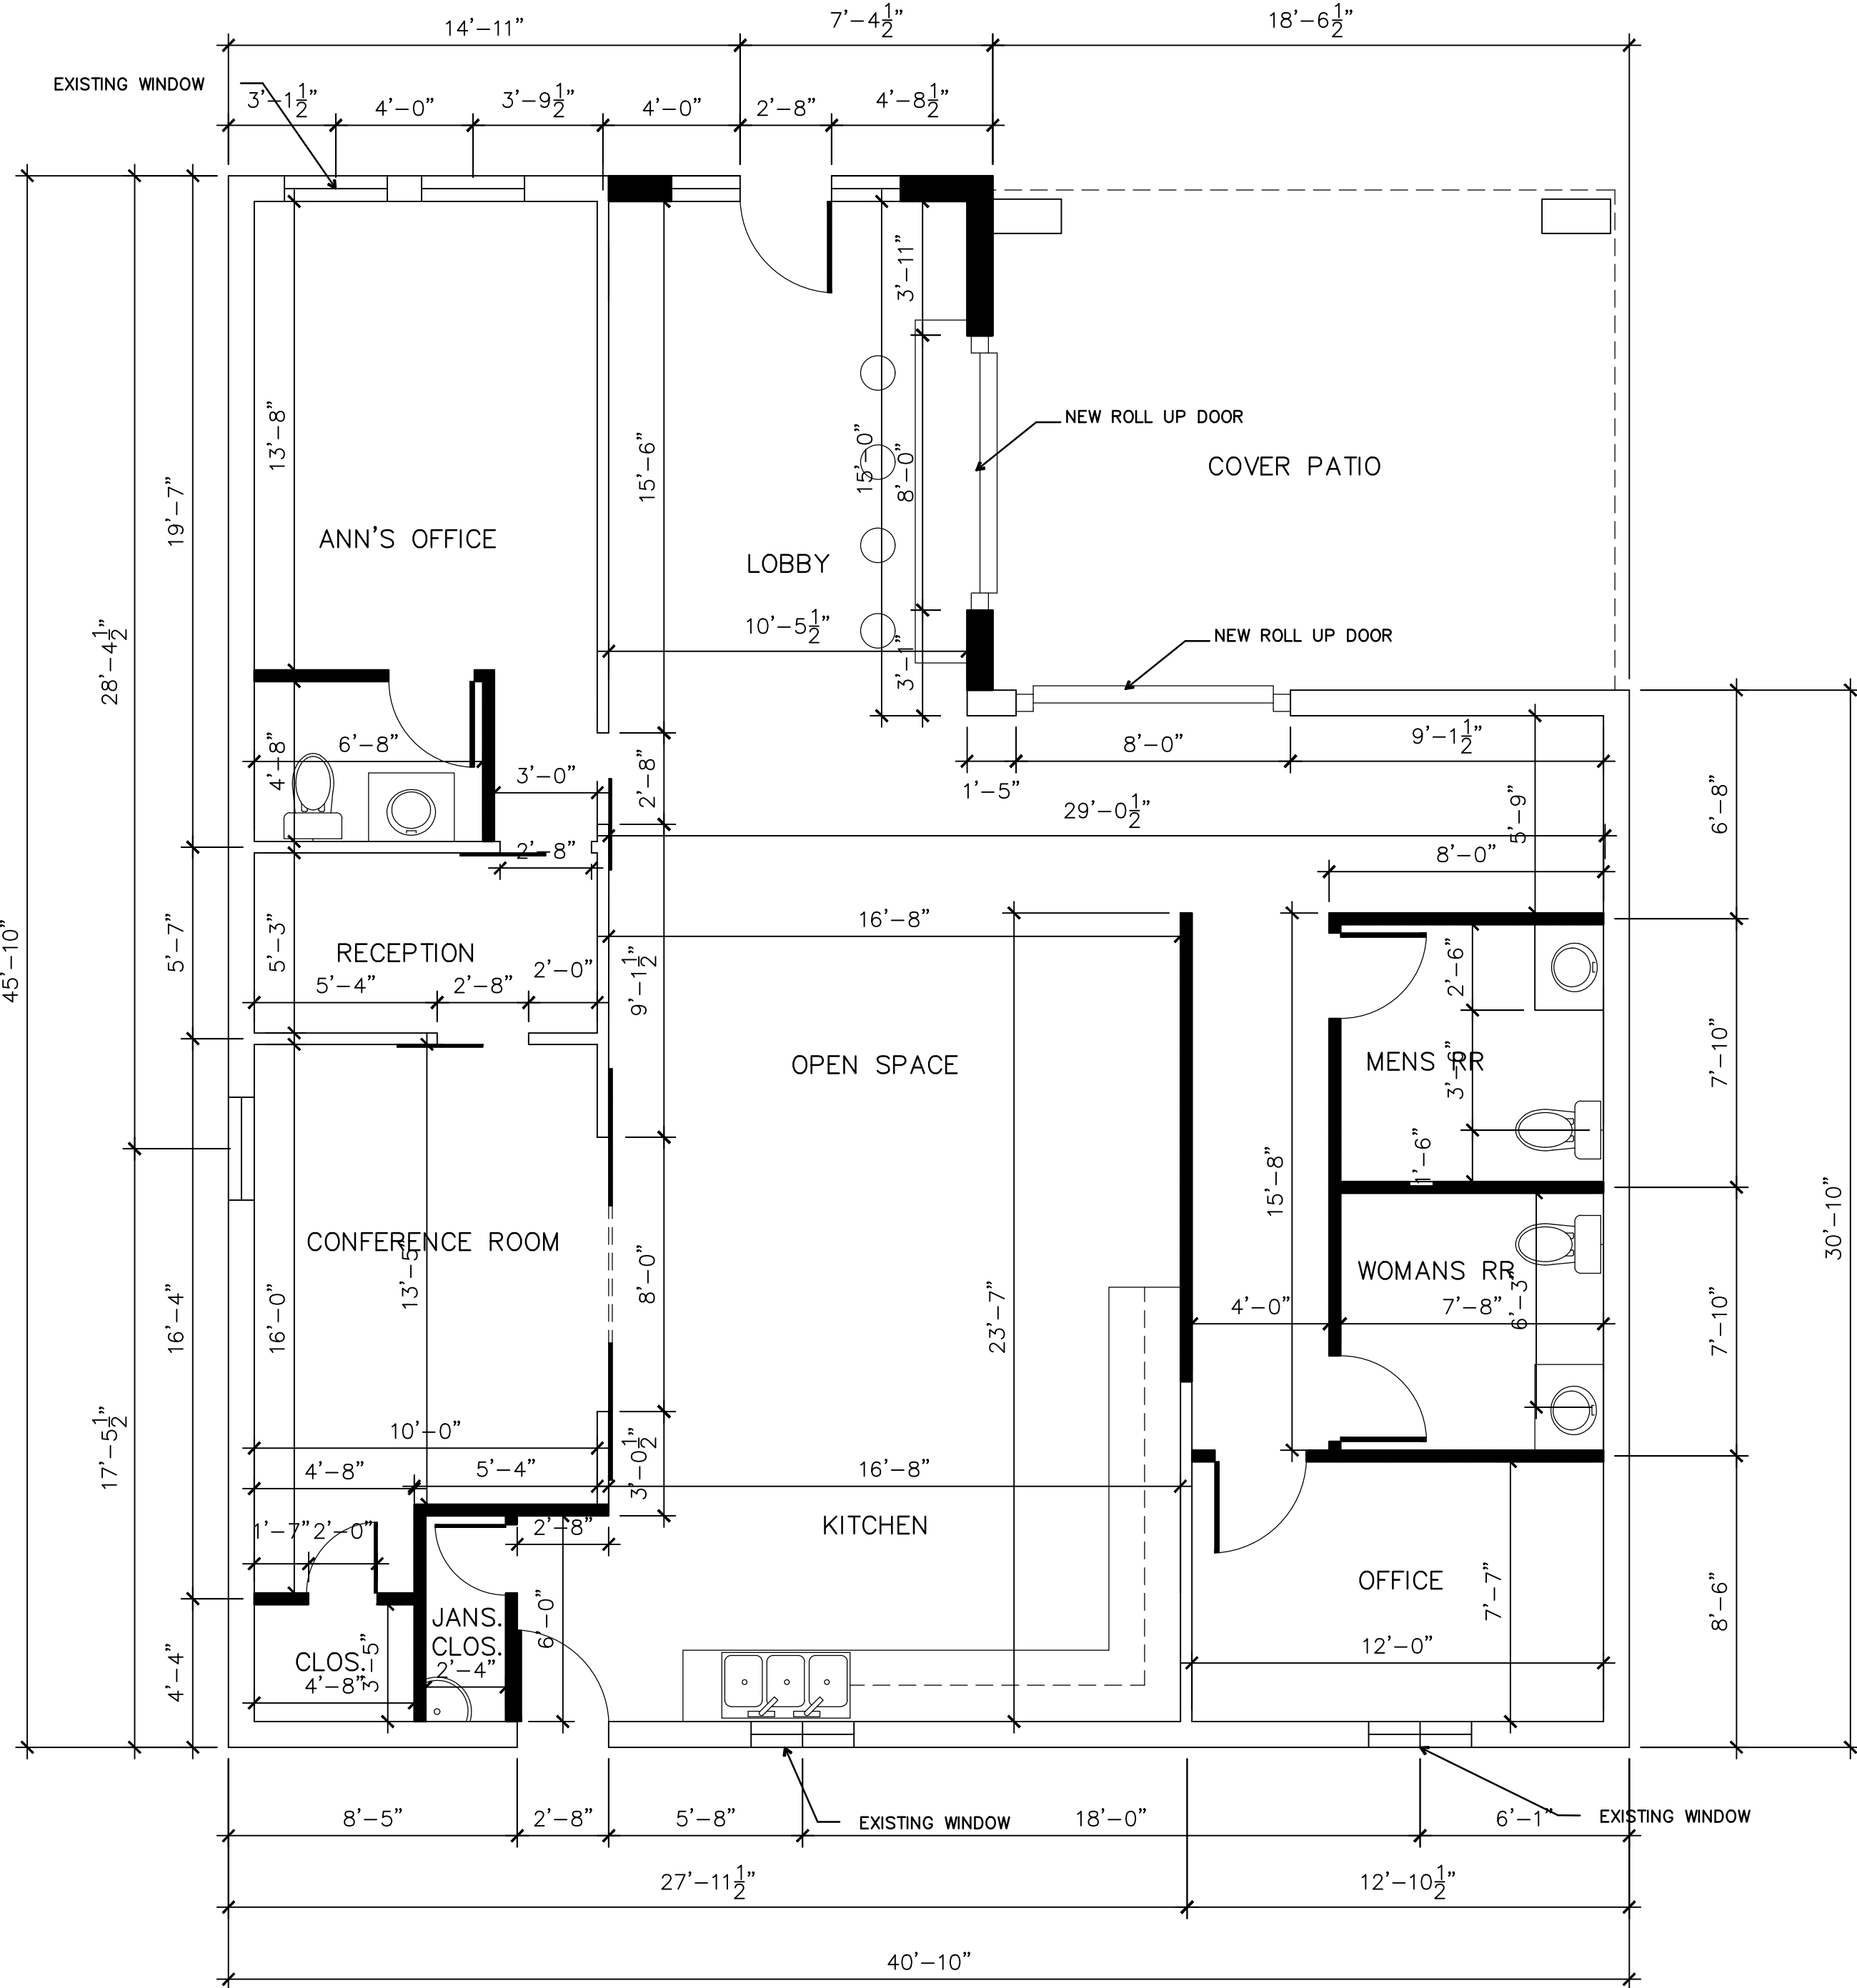

2
A1-0
PROPOSED FLOOR PLAN
SCALE 1/4"=1'-0"

- GENERAL NOTES:
1. FIELD VERIFY EXISTING FINISH FLOOR ELEVATION
 2. ALL PORCHED WALLS SHALL BE REPRESENTED AS NEW WALLS
 3. NEW DOORS SHALL BE REPRESENT WITH SYMBOL NUMBERS
 4. ALL NEW WINDOWS SHALL BE REPRESENTED WITH SYMBOL LETTERS
 5. REMOVE EXISTING WINDOWS AND REPLACE W/ FIELD VERIFY EXISTING SIZE
NEW (FIELD VERIFY TO MATCH EXISTING SIZE)
 6. REMOVE AND STORAGE PLUMBING FIXTURE FOR REPLACEMENT AND REUSED

DEMODOED WALLS
EXISTING WALLS TO REMAIN
NEW WALLS



PROPOSED REMODEL
FOR
8409 W. MONTGOMERY
HOUSTON, TX 77088

ISSUE NO. DESCRIPTION ISSUE DATE

SHEET NAME

DEMO
PROPOSED PLAN

DRAWN BY: CHECKED BY:

JOB NO.: JOB ABBR.:

DATE: JANUARY 23

SHEET NUMBER

A1-0